



Legend	
Water	Manhole
Sewer	Power Pole
Storm Sewer	Lamp Standard
Gas	Catch Basin
U.G. Telephone	Hydrant
U.G. Electrical	Trees
	L.C. (SAN)
	L.C. (STM)
	C.S.
	LPT
	SERVICE BOX


PROTECH CONSULTING 2012
 200 - 1481 St. Paul Street Kelowna B.C. Phone 850-1771 Fax 850-1924

NO.	DATE	BY	REVISION	CHK'D

DRAWN	DEW
DESIGN	IDL
APPROVED	DEP
DATE	MAY 2019
SCALE	1:500

THE CITY OF KELOWNA
 ENGINEERING DEPARTMENT
 LINDA PAHL
 BOYD ROAD
 COMPOSITE UTILITY PLAN

DIVISION	
DRAWING NO.	REV. NO.
1850-00	0

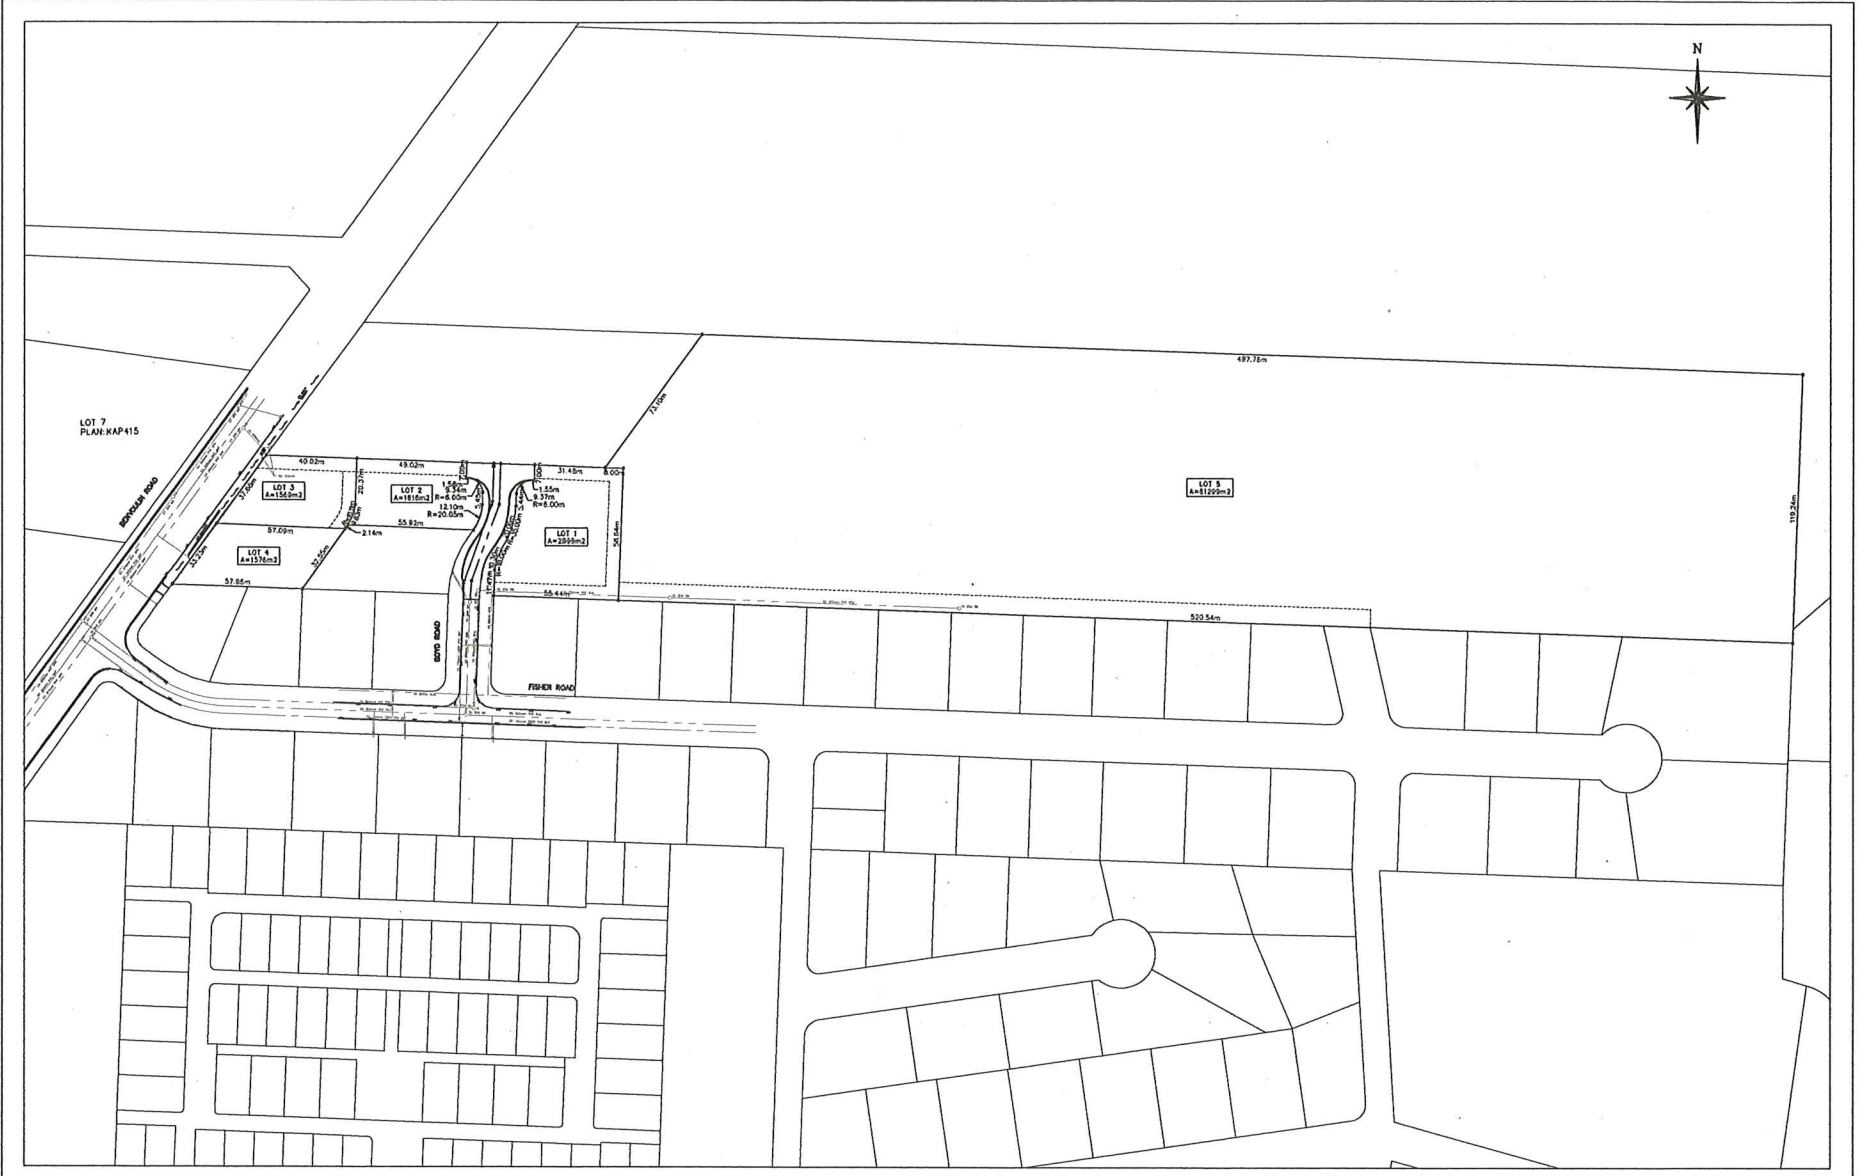

Legend	
Water	Manhole
Son. Sewer	Power Pole
Storm Sewer	Lamp Standard
Gas	Catch Basin
U.G. Telephone	Hydrant
U.G. Electrical	Tree
○	L.C. (SAN)
○	L.C. (STM)
○	C.S.
□	LPT
□	SERVICE BOX

PROTECH CONSULTING 2012
 200 - 1481 St. Paul Street Kelowna B.C. Phone 850-1771 Fax 850-1994

NO.	DATE	BY	REVISION	CHKD

DRAWN	DCW
DESIGN	KCL
APPROVED	DRP
DATE	MAY 2019
SCALE	1:1000

THE CITY OF KELOWNA
 ENGINEERING DEPARTMENT
 LINDA PAHL
 BOYD ROAD
 COMPOSITE UTILITY PLAN

DIVISION	
DRAWING NO.	REV. NO.
1850-00	0